


HGACBuy
October 1-2, 2019
NRG Center - Hall E2 - Level
Houston, TX



Show Information	
Show Name	HGACBuy
Show Dates	October 1-2, 2019
Move-In	September 30, 2019
Job #	T161881019
AE	Tyler Jo Reason

Inventory as of 08/28/2019

Dimension	Size	Qty
10'x10'	100	46
20'x20'	400	5
Totals:		51

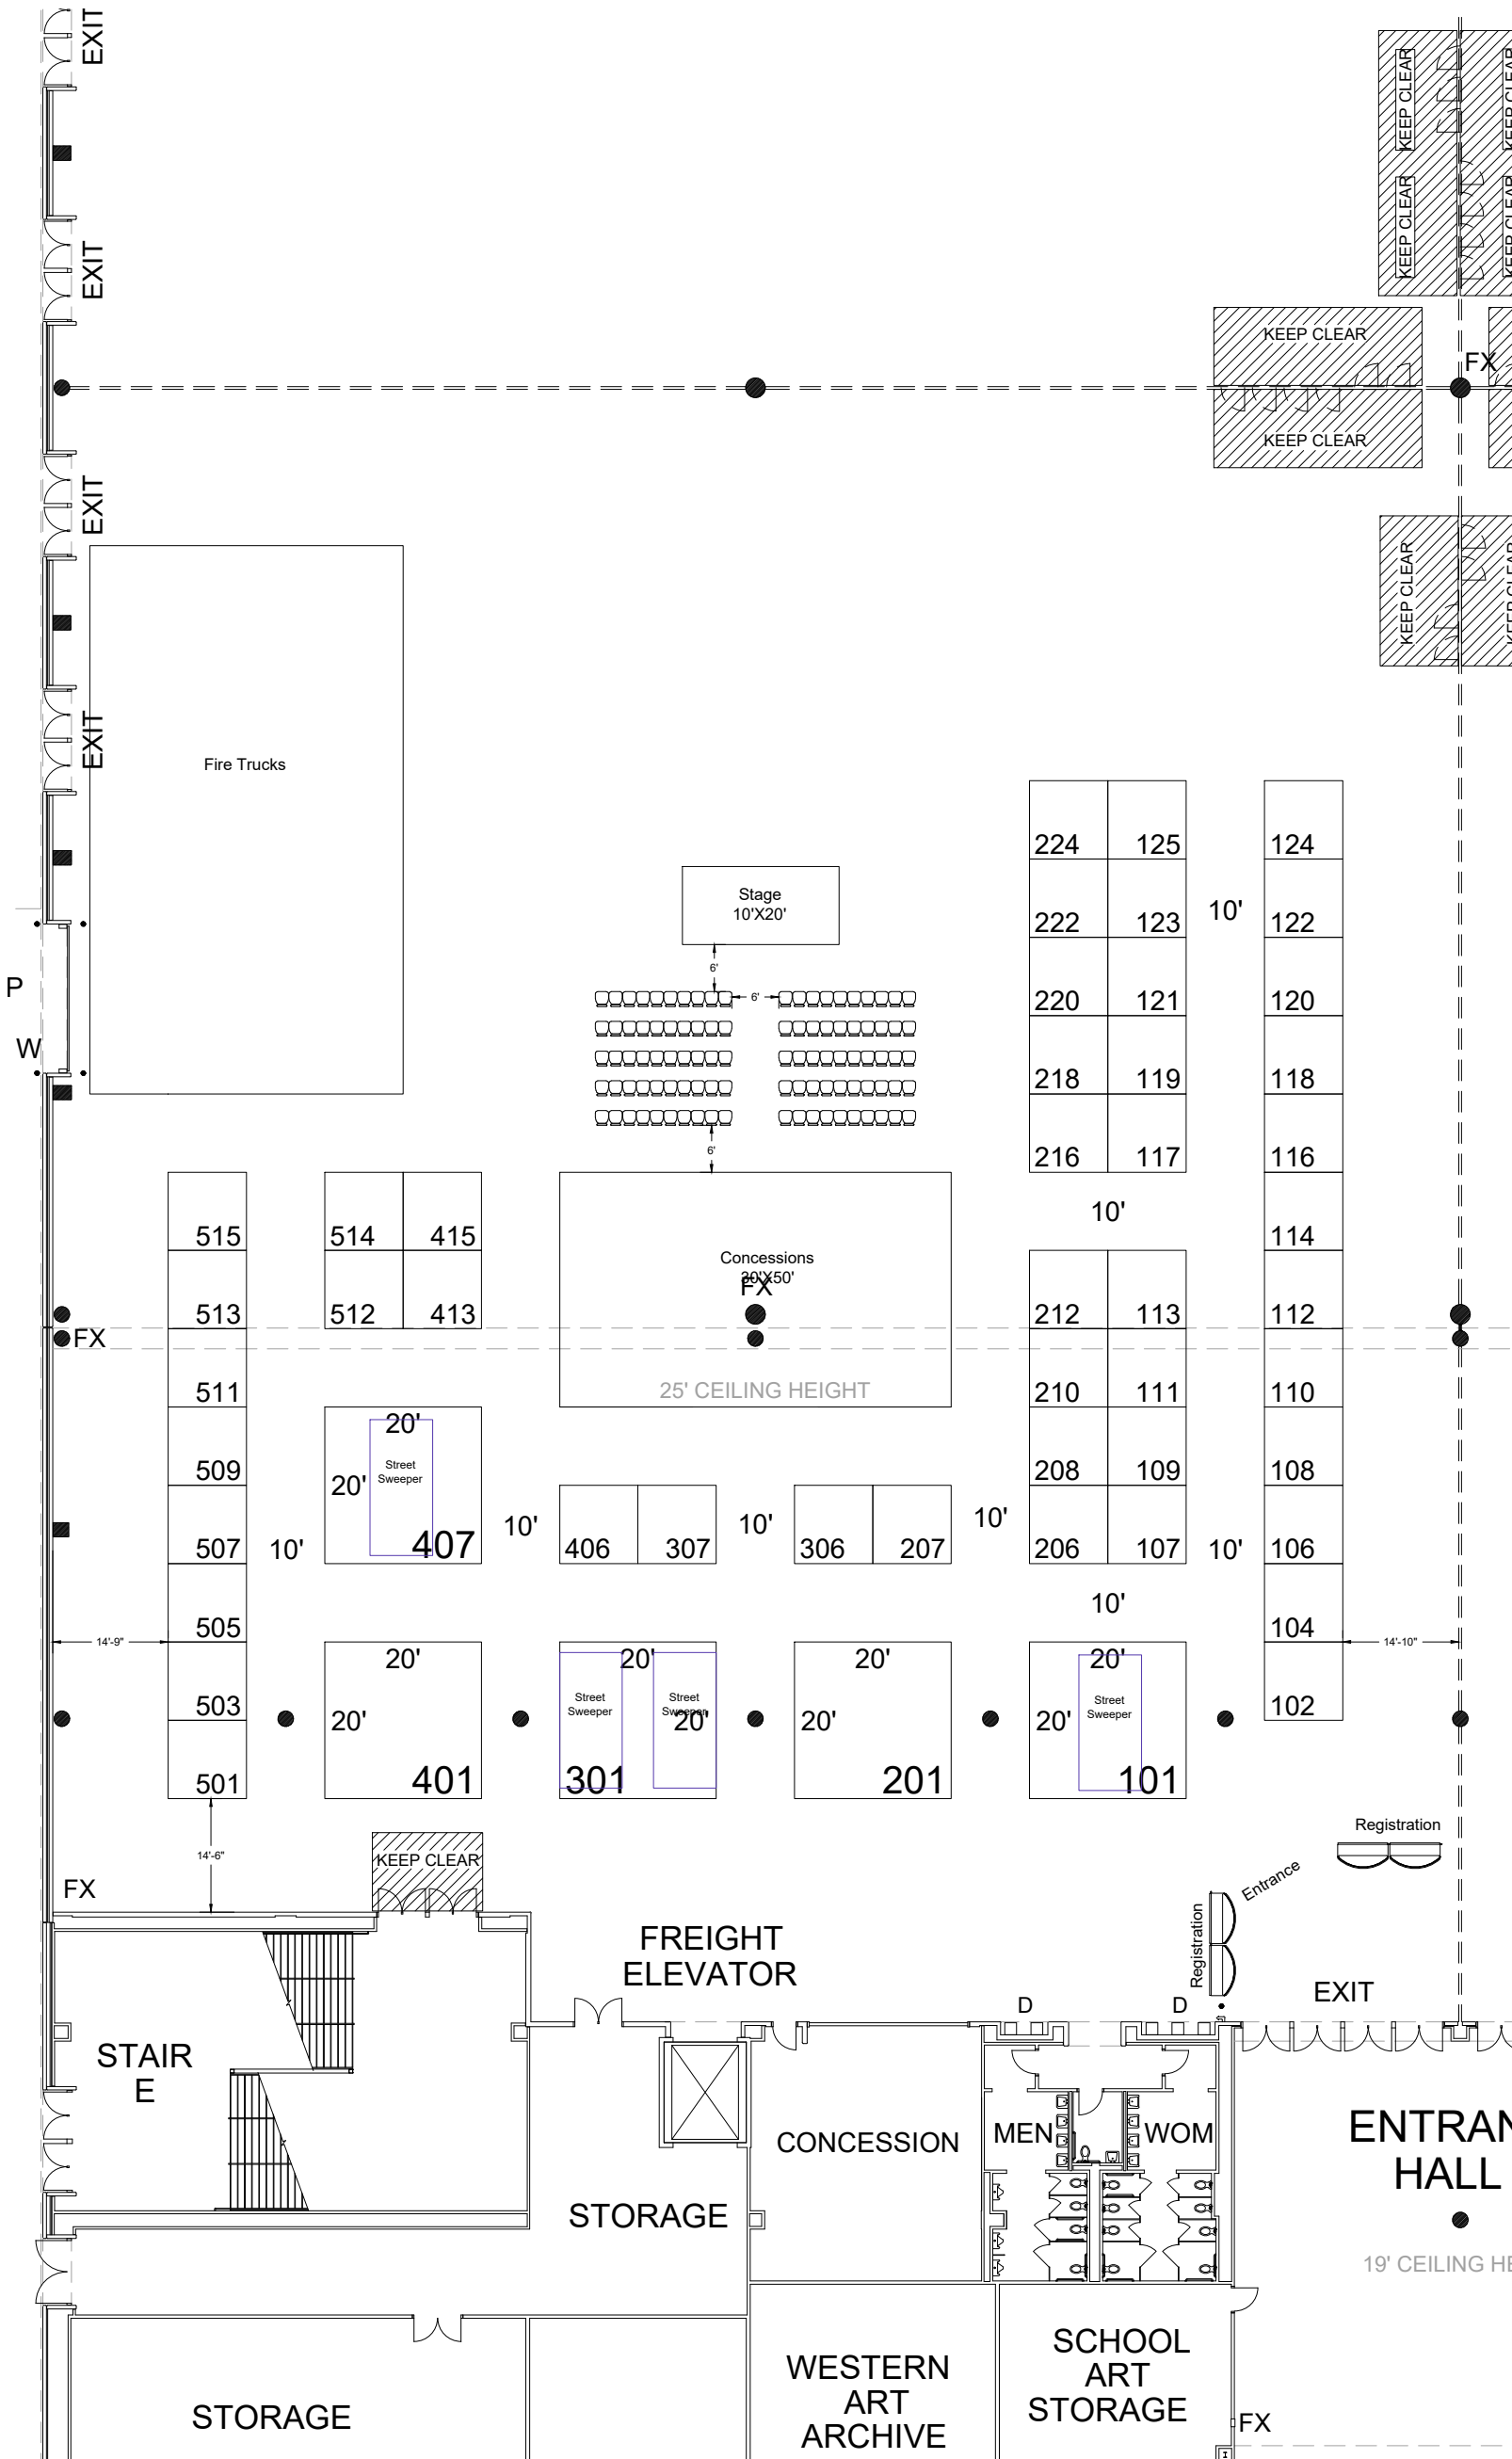

Floor Plan Legend	
FE	Fire Extinguisher
FS	Fire Strobe
FHC	Fire Hose Cabinet

Venue Info	
Building Name	NRG Center
Hall	Hall E2
Floor	Level
Address	One Reliant Park Houston, TX 77054

Drawing Information	
File Path	J:\01_Floor Plans_01_SEE SHOW FLOORPLANS\201910_02\HGACBuy_T161881019.dwg
File Name	HGACBuy_T161881019.dwg
Drawn By	RP
Last Saved	8/28/2019 11:35 AM
Saved By	Rperry
Tab	Floorplan
Paper Size	ANSI expand B (11.00 x 17.00 inches)
Scale	NTS

1531 Carroll Drive NW
 Atlanta, GA 30318
 (v) 404-720-8600
 (f) 404-720-8750

Shepard Exposition Services has made every effort to ensure the accuracy of all information contained on this floor plan. However, no warranties, either expressed or implied, are made with respect to this floor plan. Verifying the locations of building columns, utilities, or other architectural components of the facility is the sole responsibility of the exhibitor/show management.

SUBJECT TO FIRE MARSHAL APPROVAL